


	暖通	
	建筑	
	结构	
	电气	
	给排水	
	建	

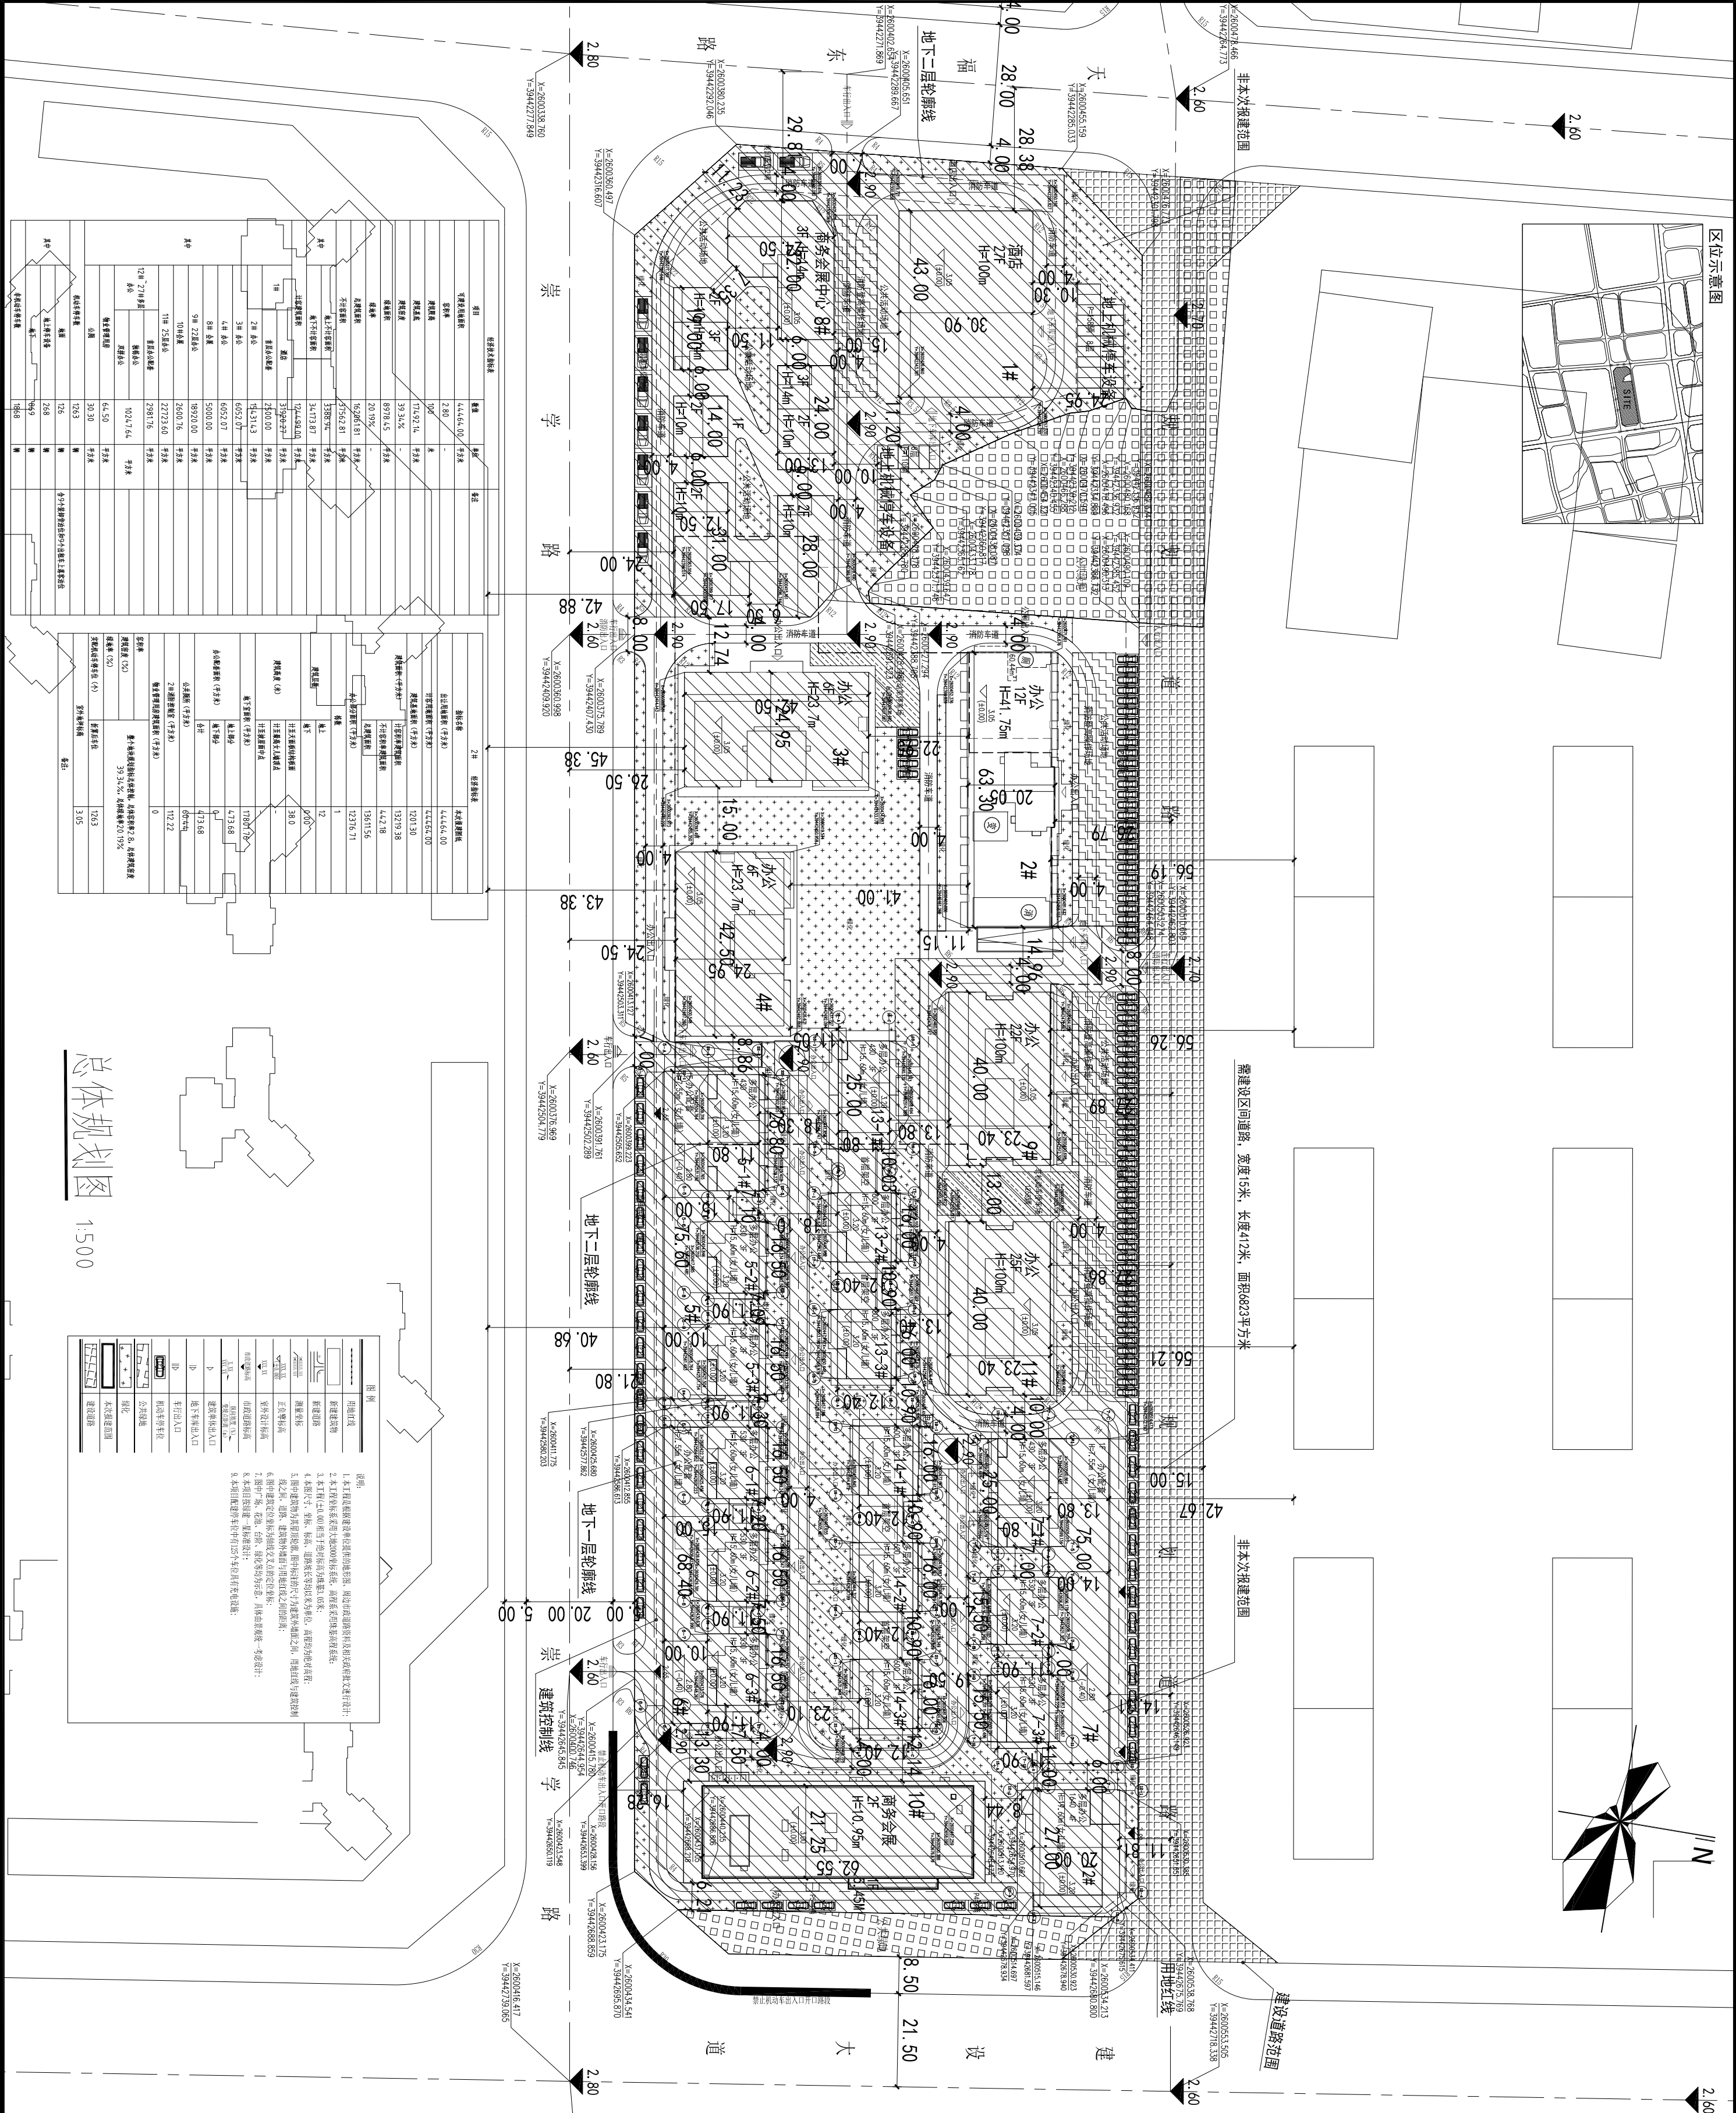

(1) In case scale drawing. Planned dimensions are to be followed. Read this drawing in conjunction with all other relevant drawings and specifications therein.
The designer shall be notified immediately of any discrepancy found therein.
所有尺寸应以图纸上所注之数字为准，不能以比例尺量取。使用此图时，应同时参阅所有相关之图纸及施工说明书。如有任何不符之处，应立即以书面通知设计者。
(2) This drawing shall not be used for construction purposes unless signed and approved. The contractor shall verify all dimensions on site prior to commencement of work.
除非已经签署及批准外，此图不能作为施工之用。承建单位须先复核工地之实际尺寸，方可正式动工。
(3) The copyright of this schedule / drawing may be reproduced in any form or by any means without the written permission from this company.
此图纸/表格之版权仍为本公司所有，未经本公司之书面许可，不得以任何形式及方法复制或翻印全部或部分内容。

盖章	
Stamp	
图审编号 日期	
Rev. No.	Date
内容摘要	
Particulars	Initial
设计	
审核	
审定	

项目负责人	
Project Chief	
专业负责人	
Chief Designer	
校对	
Checked By	
设计	
Designed By	
绘图	
Drawn By	
建设单位	
Jian Unit	
工程名称	
Jin Title	
揭阳绿美房地产开发有限公司	
揭阳绿美国际空港城地块三	
图纸名称	
Drawing title	
总体规划图	
业务号	
Job No.	
日期	
Date	
2025.6	
版次	
Issue	
01	
专业	
Discipline	
建筑	
GP-01	
图号	
Drawing No.	
比例	
Scale	
1:500	
设计阶段	
Status	
GP	

总体规划图

1:500